

April 2017
 Revised to Conform to
 Construction Records
 City of Verona Public Works/ Sewer & Water
 By
 Marten J. Cieslik, P.E.

REGISTRATION

ISSUE/REVISION

I/R	DATE	DESCRIPTION
R	05/10/2016	ADDENDUM NO. 1

KEY PLAN

PROJECT NUMBER

60446021



SHEET TITLE

PLAN AND PROFILE
 SCHOOL PRIVATE DRIVE

10-183

SHEET NUMBER

PP-8

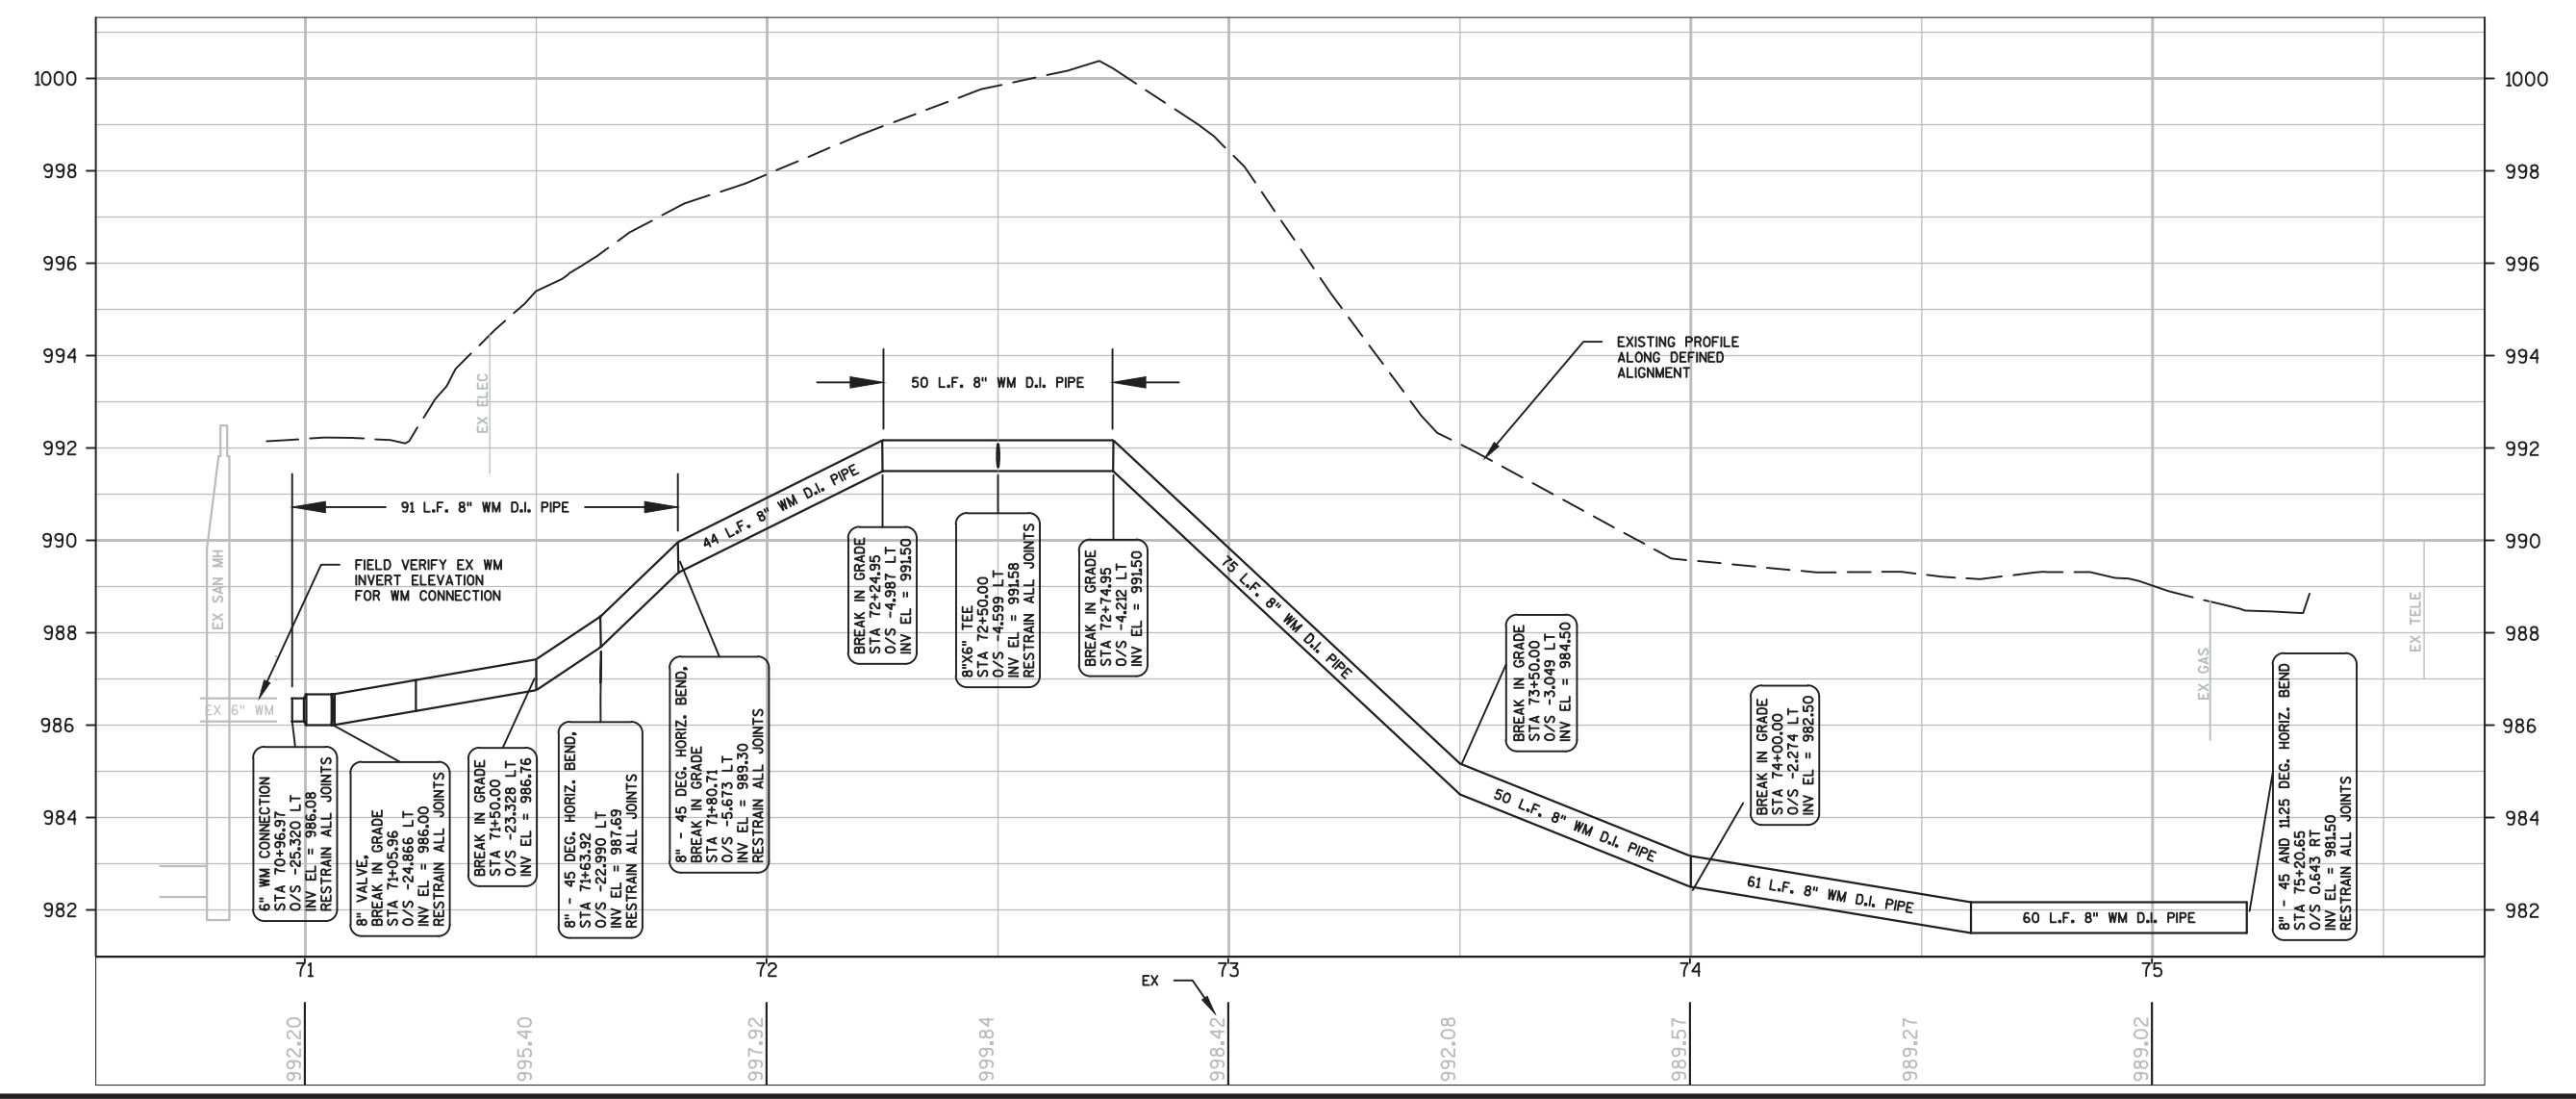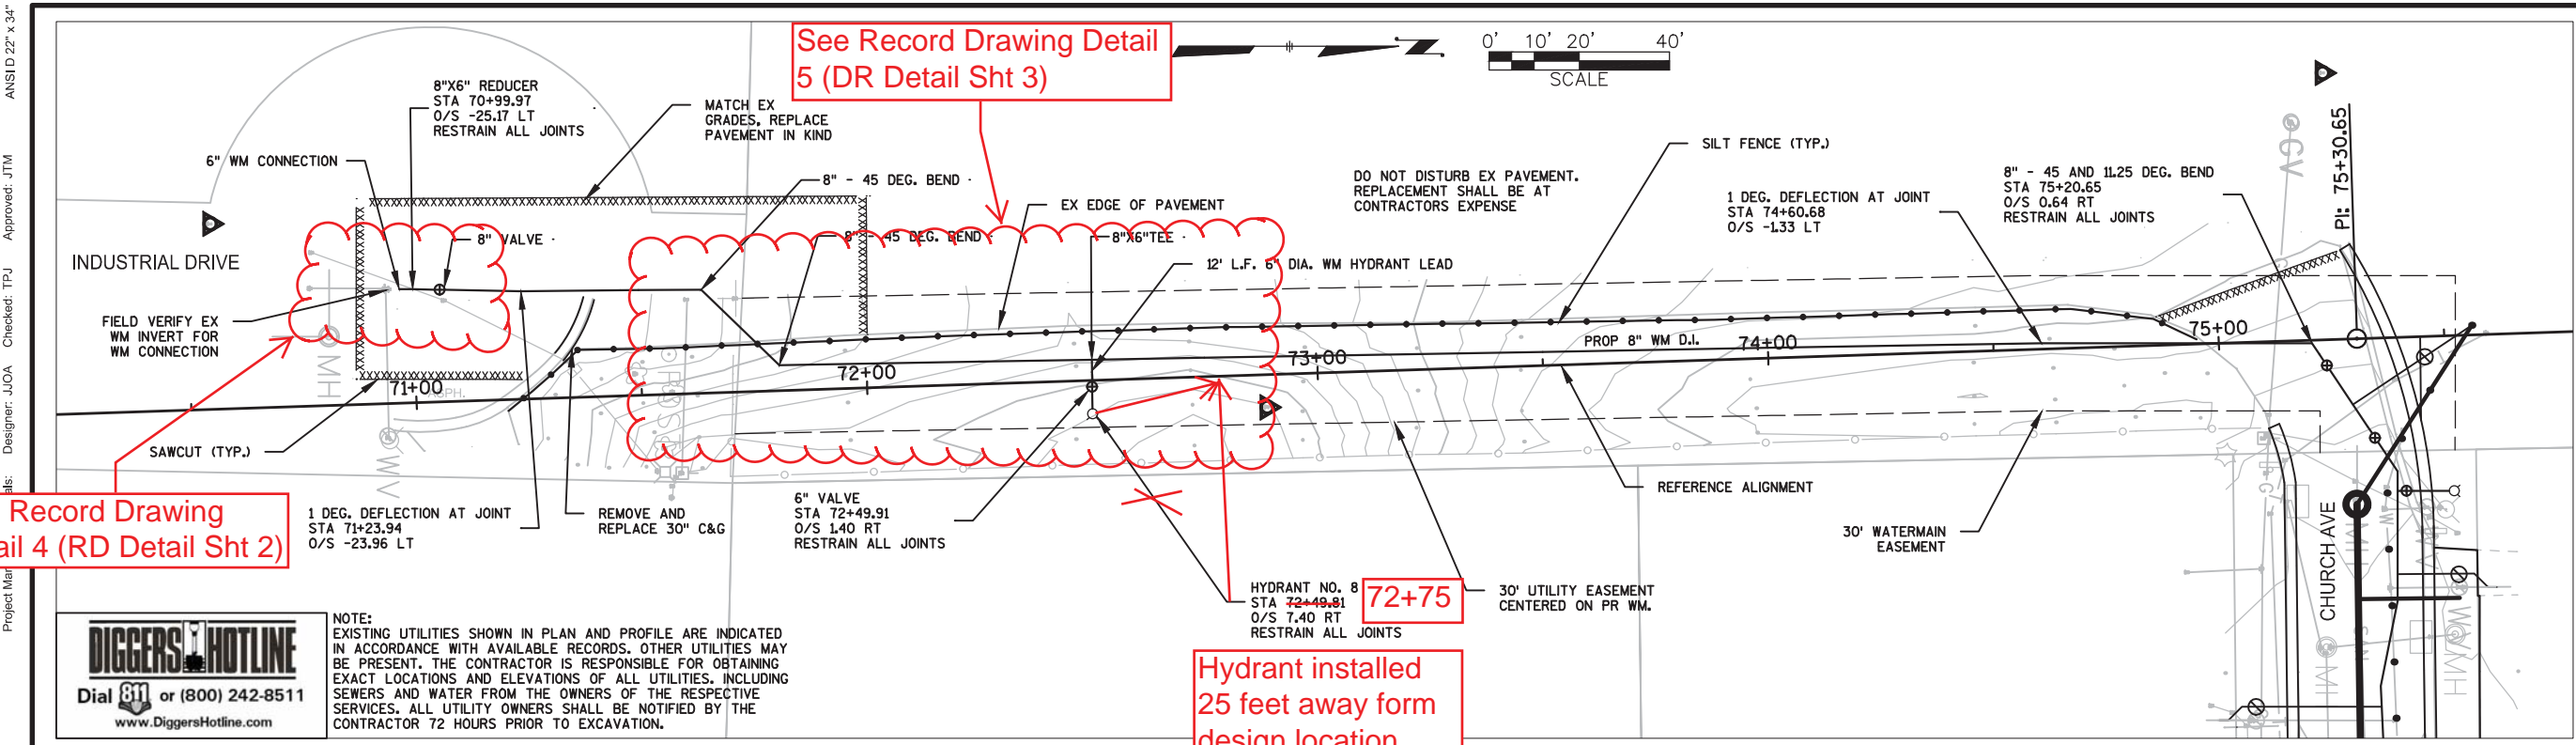

ANS I D 22" x 34"
 Project Manager: JCOA
 Designer: JCOA
 Checked: TPJ
 Approved: JTM
 Plotted By: accolaj
 Plot File Date Created: May/10/2016 11:09 AM
 Layout-Sheet Name: PP-8
 Filename: P:\60446021\900_WORK\910_CAD_WORKING\AE_0305_P1_PP - SCHOOL.DWG